

REVISIONS		DRAWN		PREPARED		PRELIMINARY NOT FOR CONSTRUCTION (PROFESSIONAL SEAL AS REQUIRED)	
NO.	DATE	REMARKS	Author	Author	Approver	Approver	SEAL NO. (REQUIRED)
			Checked	Checked	Approved	Approved	
			Checked	Checked	Approved	Approved	

CAPITAL Development BOARD
 State of Illinois
 Bruce Rauner, Governor
 Capital Development Board





LEVEL 02 AREA 1 FURNITURE AND EQUIPMENT PLAN
 CAMPUS LIFE / ONE STOP ADMISSIONS
 HARPER COLLEGE
 PALATINE, ILLINOIS

PROJECT NO.
 DATE
 SHEET NO.
A1102-1

NOTE: CONTRACTOR SHALL VERIFY ALL DIMENSIONS AND CONDITIONS AT JOB SITE AND BE FULLY RESPONSIBLE FOR SAME.

100% CONSTRUCTION DOCUMENTS — PRINTING FOR CDB HOLD

1 LEVEL 02 FLOOR PLAN
 1/8" = 1'-0"

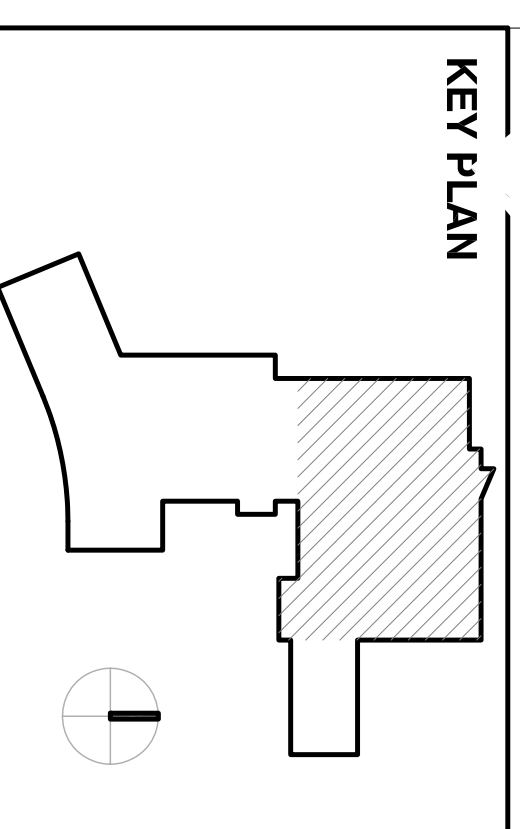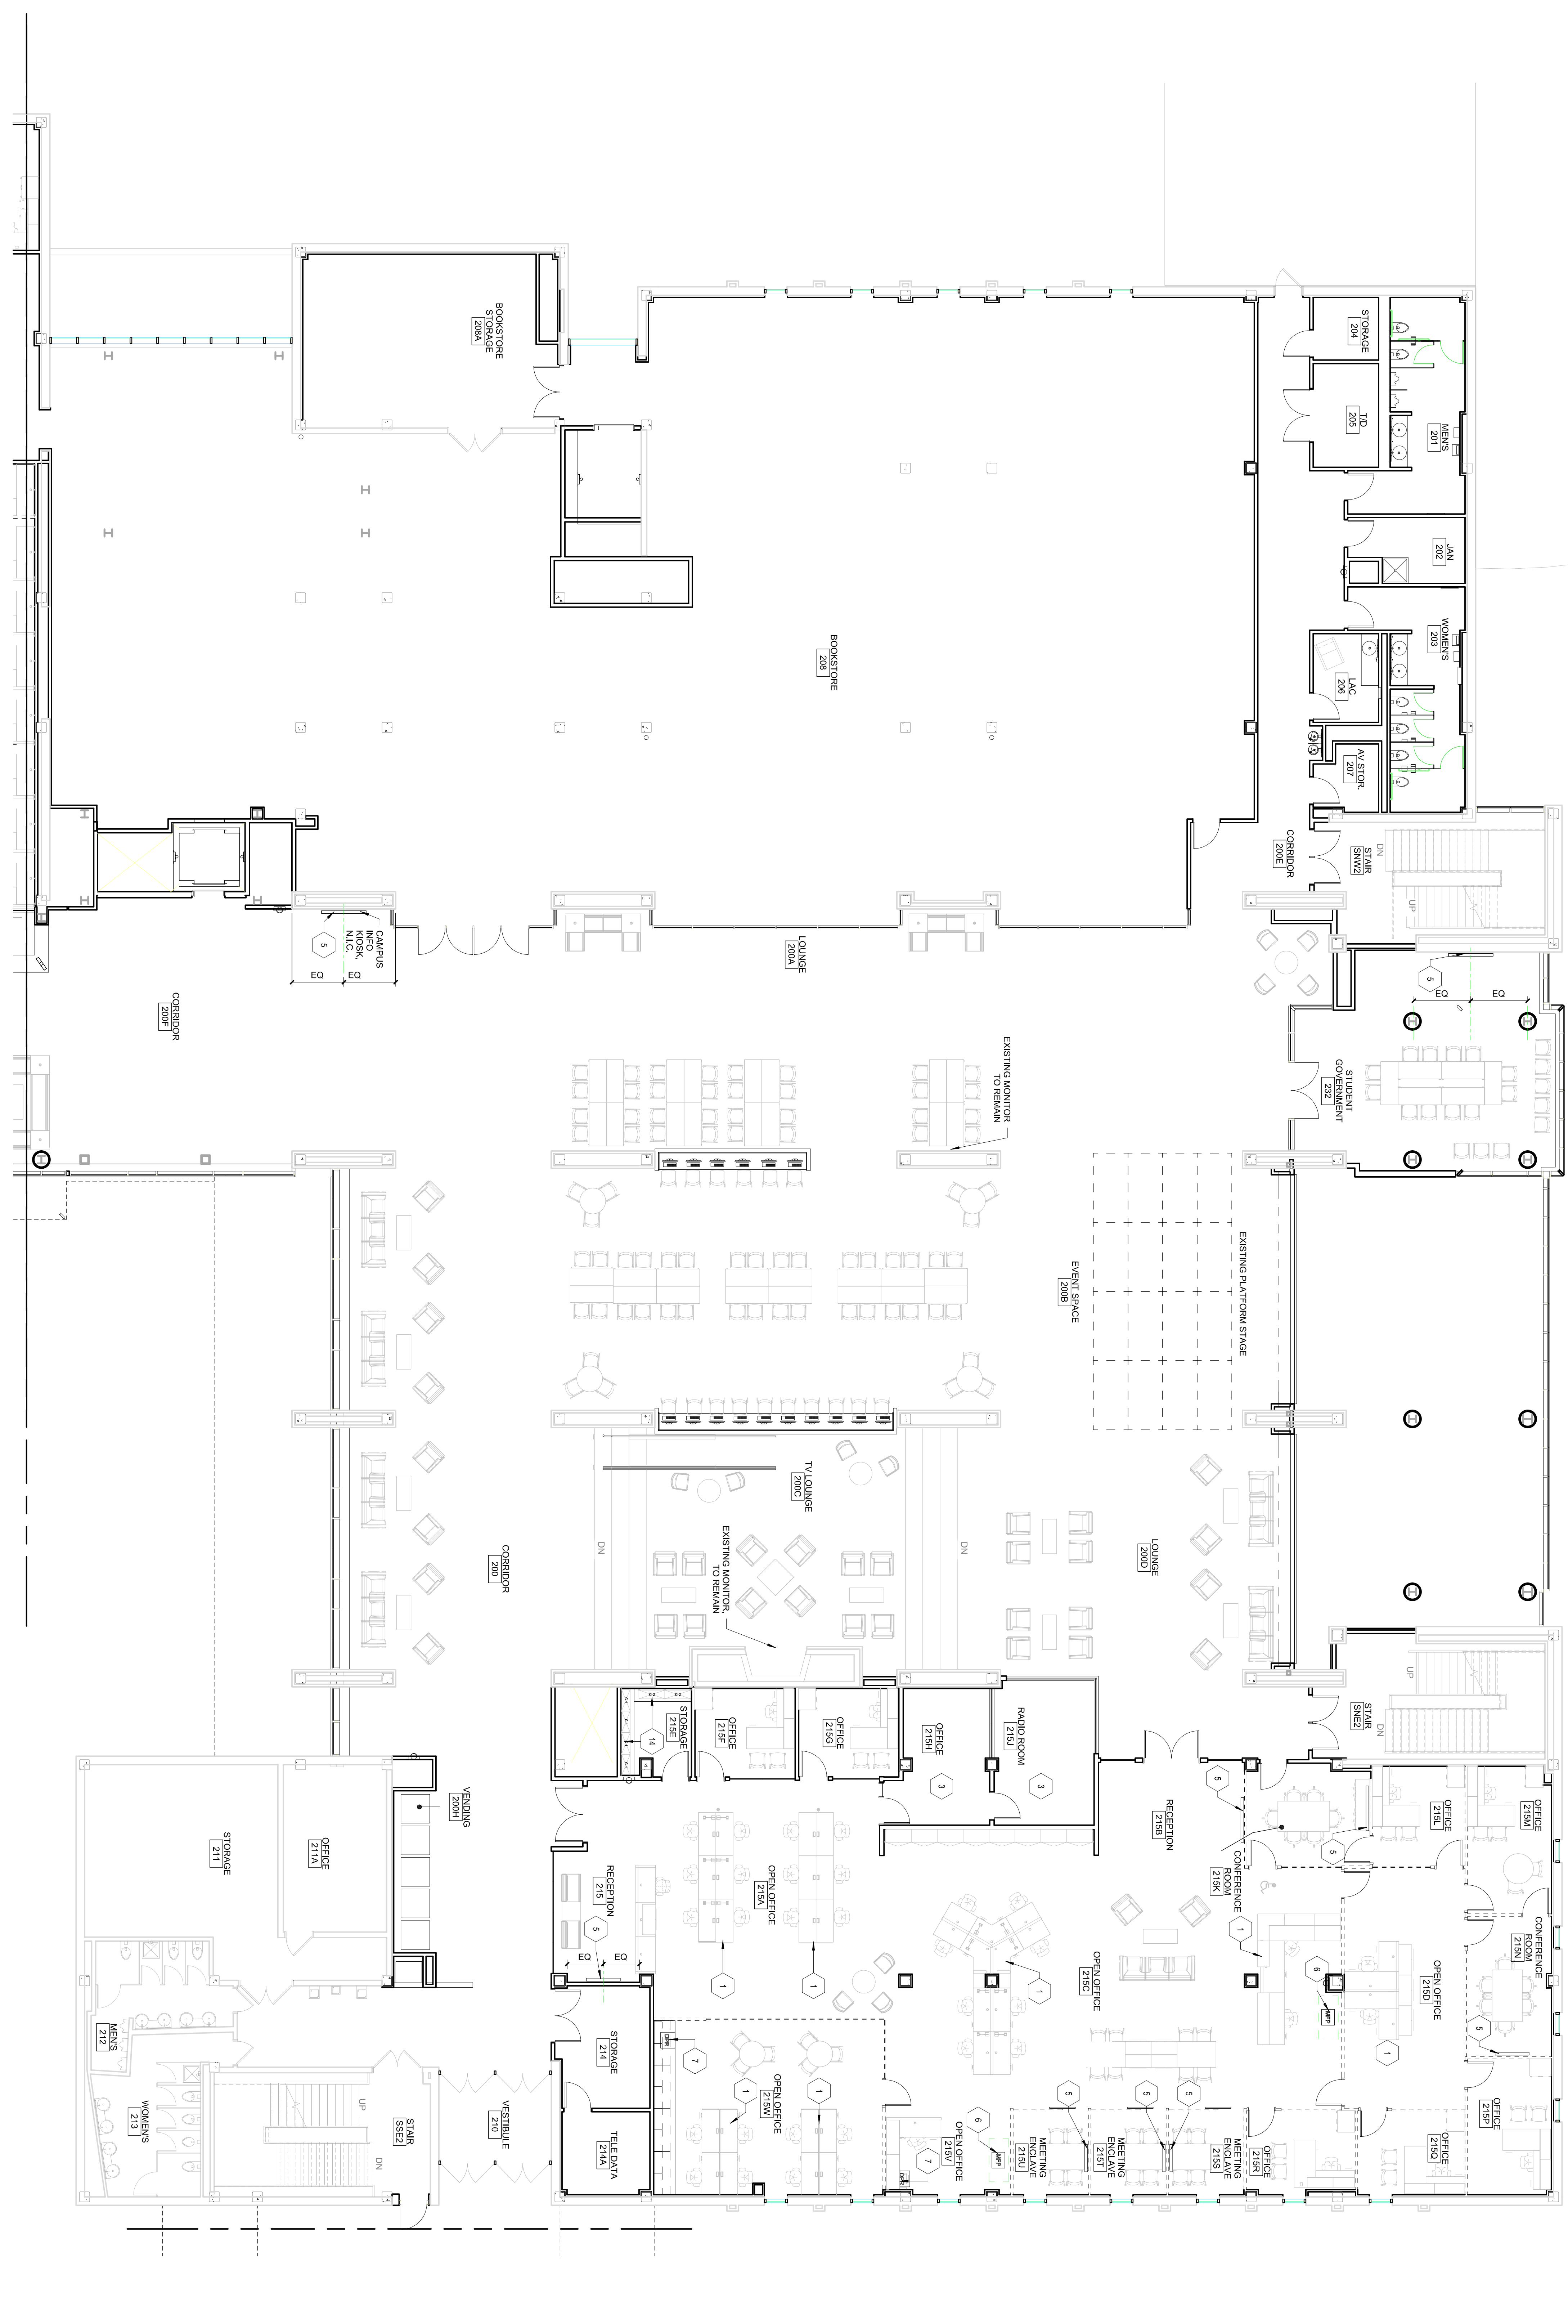

FOR REFERENCE ONLY

- GENERAL SHEET NOTES**
- FURNITURE & EQUIPMENT NOT IN CONTACT (NFC) FOR REFERENCE ONLY. FURNITURE PROVIDED BY OTHER CONTRACTORS.
 - ELEVATION TAGS & SHEETS A&V SERIES FOR ELEVATIONS.
 - REFER TO SHEETS T100 SERIES FOR PROJECT AND SYSTEMS PLAN.
 - REFER TO SHEETS T100 SERIES FOR TELECOMMUNICATIONS PLAN.
 - REFER TO SHEETS T300 SERIES FOR PROJECT AND SYSTEMS PLAN.
 - REFER TO SHEETS T300 SERIES FOR PROJECT AND SYSTEMS PLAN.
- REFERENCE KEYNOTES**

- SHEET KEYNOTES**
- POWERED FURNITURE, A.L.C. BY FURNITURE.
 - POWERED NETWORK, REFER TO DETAILS & ELEVATIONS.
 - NON-POWERED NETWORK, REFER TO DETAILS & ELEVATIONS.
 - ELEVATION FOR ELECTRICAL DATA COMBINATION, REFER TO SHEETS T100 SERIES.
 - WALL MOUNTED MONITOR, N.C.
 - MPR - MULTIFUNCTIONAL PRINTER, N.C.
 - MPR - DEPTOP PRINTER, N.C.
 - MPR - SHEARING BIN, N.C.
 - MPR - SHREDDER, N.C.
 - MPR - SCANNER, N.C.
 - PROJECTOR, N.C.
 - LETTERER, N.C.
 - LAPTOP CHARGING CARTS, N.C.
 - DIGITAL CLOCK IN TESTING LABS, REFER TO ELECTRICAL DATA COMBINATION.
 - ADJUSTABLE REPORT SHELVING ON STAIRWELLS, BY METROFRONTIER.
 - CHECKOUT KIOSK, A.L.C.
 - WALL MOUNTED POWERED EQUIPMENT, A.L.C.
 - PROJECTOR SCREEN, REFER TO ELECTRICAL DATA COMBINATION, SERIES T100.
 - TELECOMMUNICATION DRAWINGS, SERIES T100.